


Blaylock Engineers
 Mechanical and Electrical Engineering
 1009 McKee Street, San Diego, Calif. 92110
 (714) 591-5400

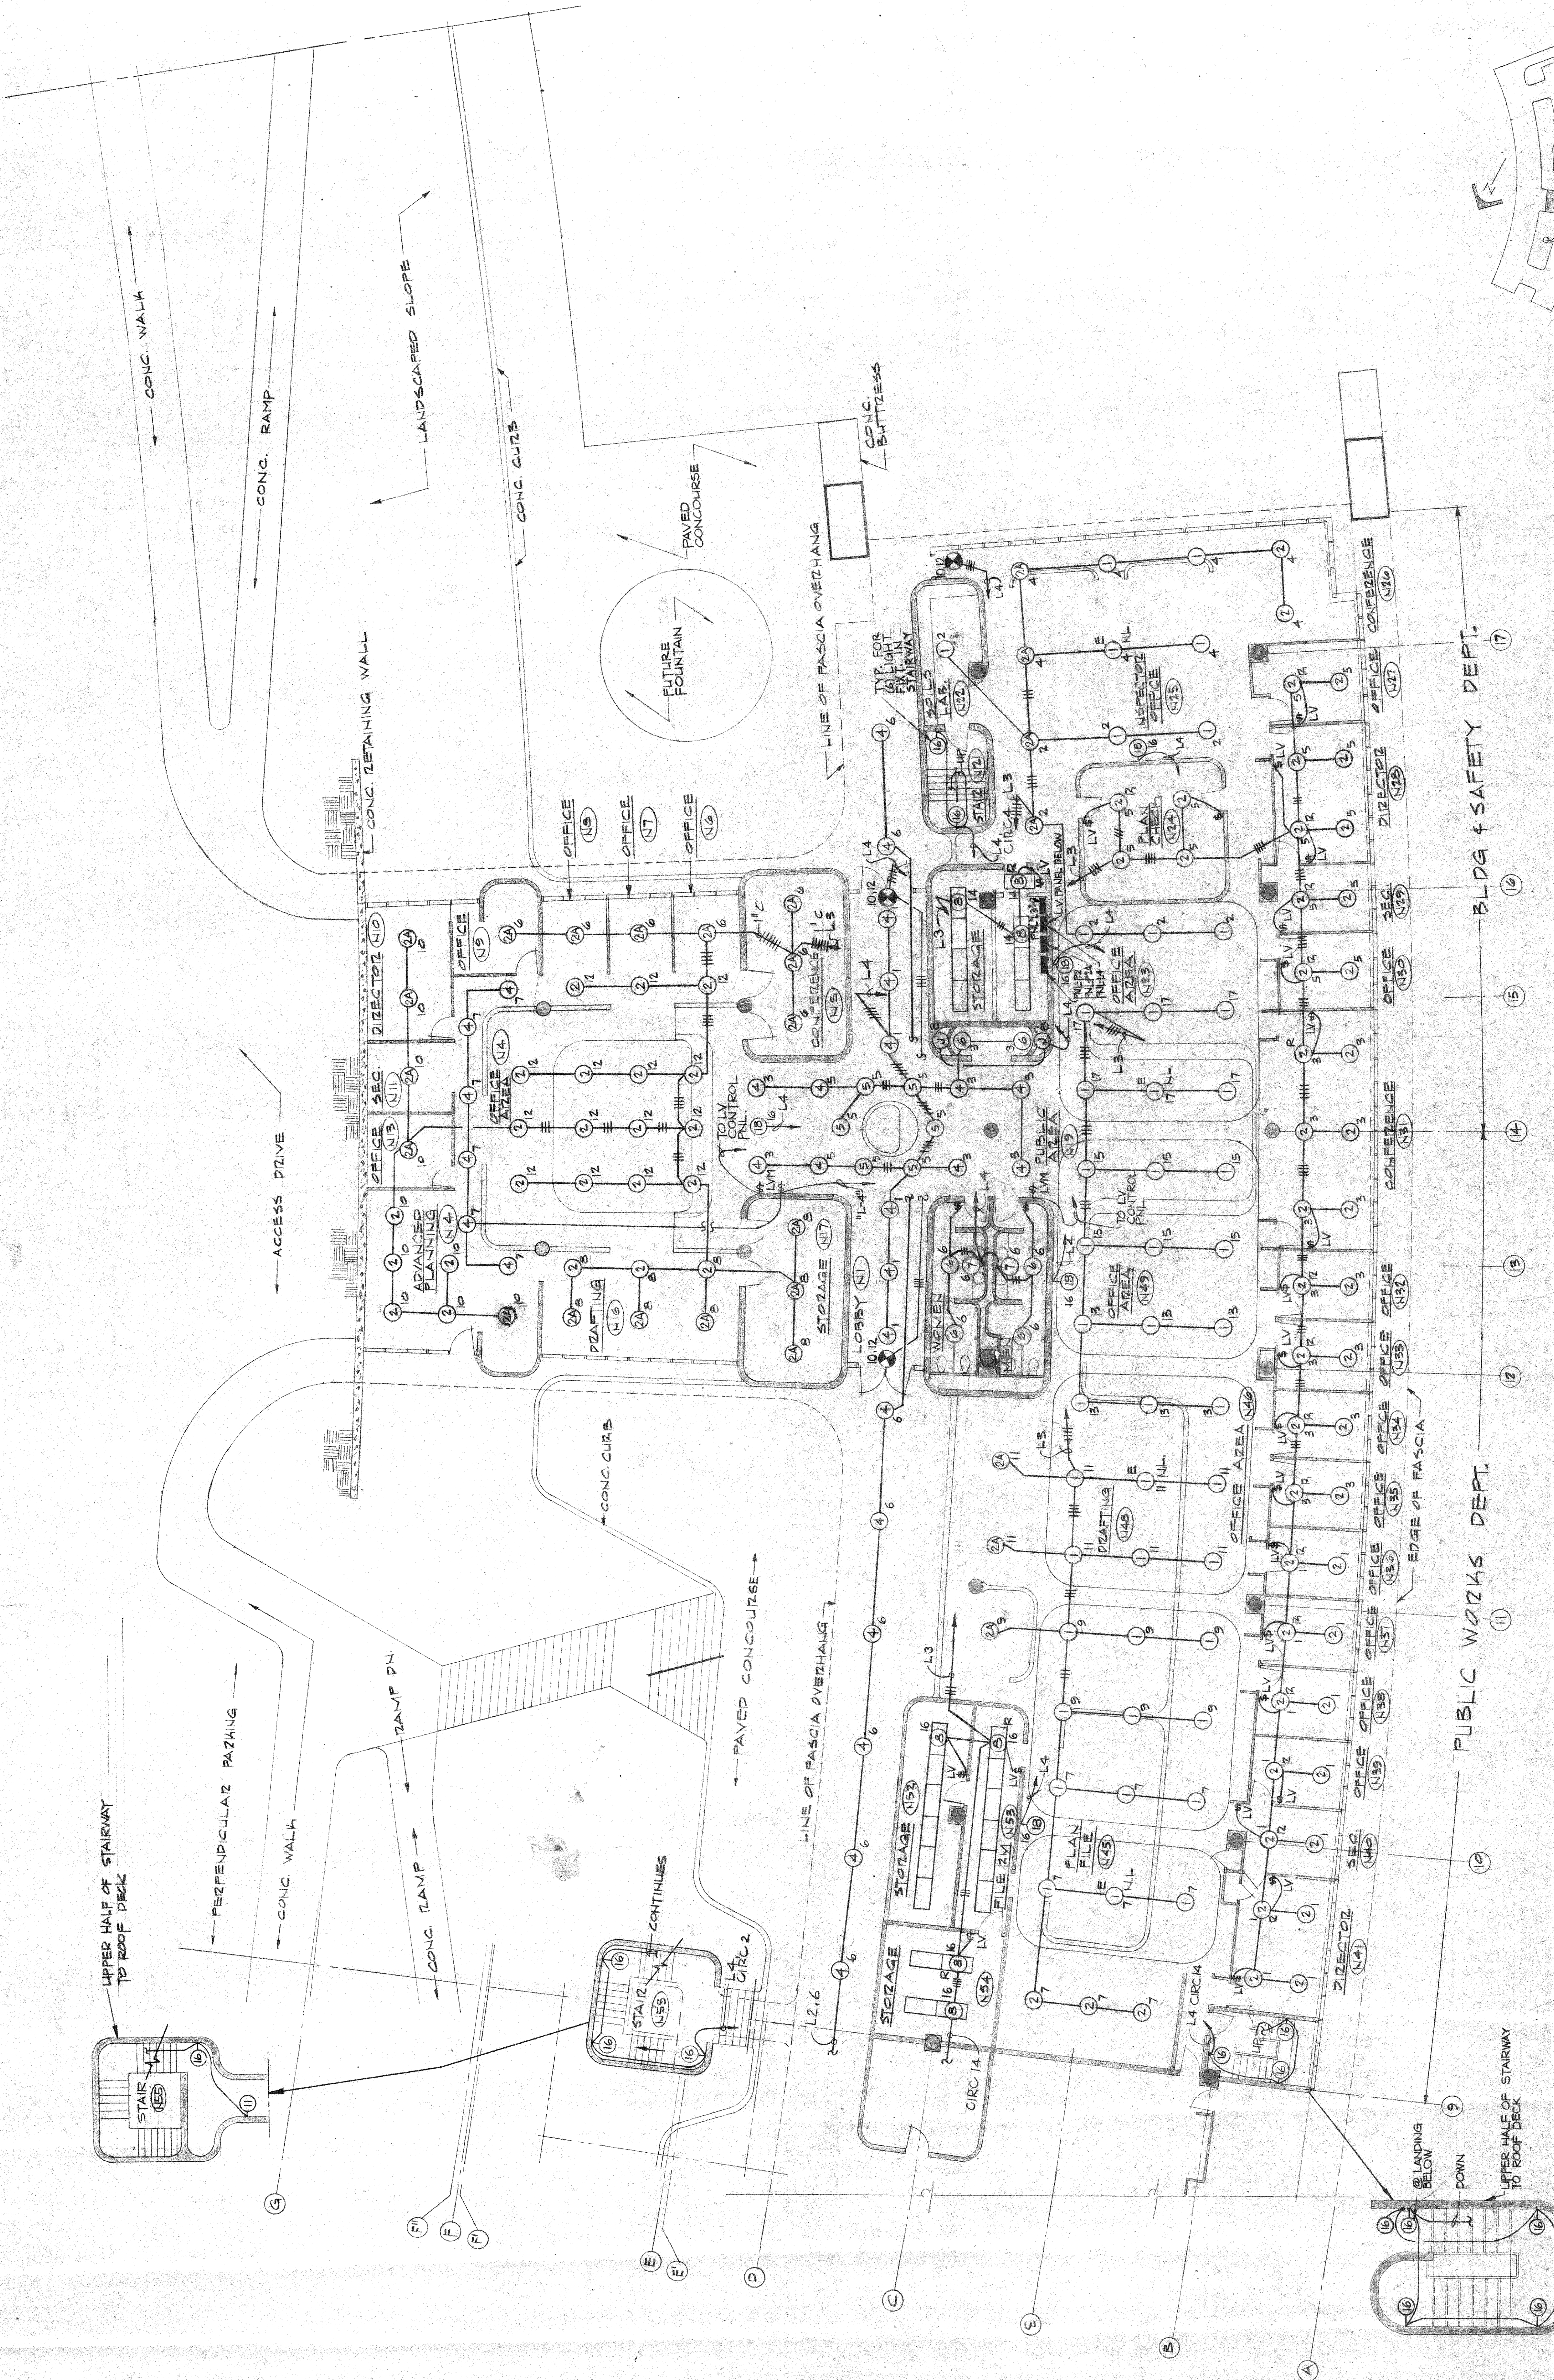

LIGHTING PLAN-NORTH BUILDING-SOUTH END
 SCALE 1/8"=1'-0"

PUBLIC WORKS DEPT.

BLDG & SAFETY DEPT.

