


GAS PIPING DIAGRAM
 NO SCALE

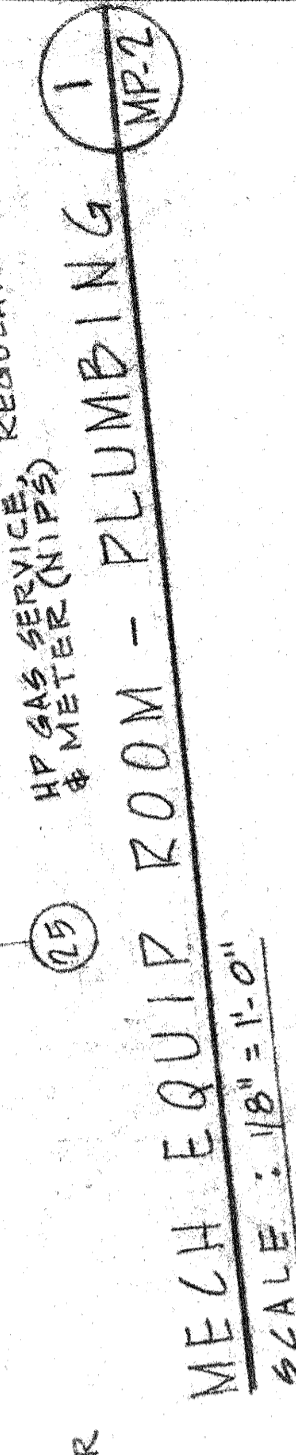

MECH EQUIP ROOM - PLUMBING
 SCALE: 1/8" = 1'-0"

FLOOR PLAN - SOUTH BLDG - PLUMBING & PIPING
 SCALE: 1/8" = 1'-0"

Baylock Engineers
 Mechanical and Electrical Engineering
 1809 McKee Street, San Diego, Calif. 92110