



SHEET NOTES

1. SEE SHEETS MP-12 & MP-13 FOR MECHANICAL LEGEND & EQUIPMENT SCHEDULES
2. COORDINATE WITH ARCHITECTURAL REFLECTED CEILING PLAN SHEET A-16 FOR REGISTERS, GRILLES & DIFFUSERS LOCATIONS

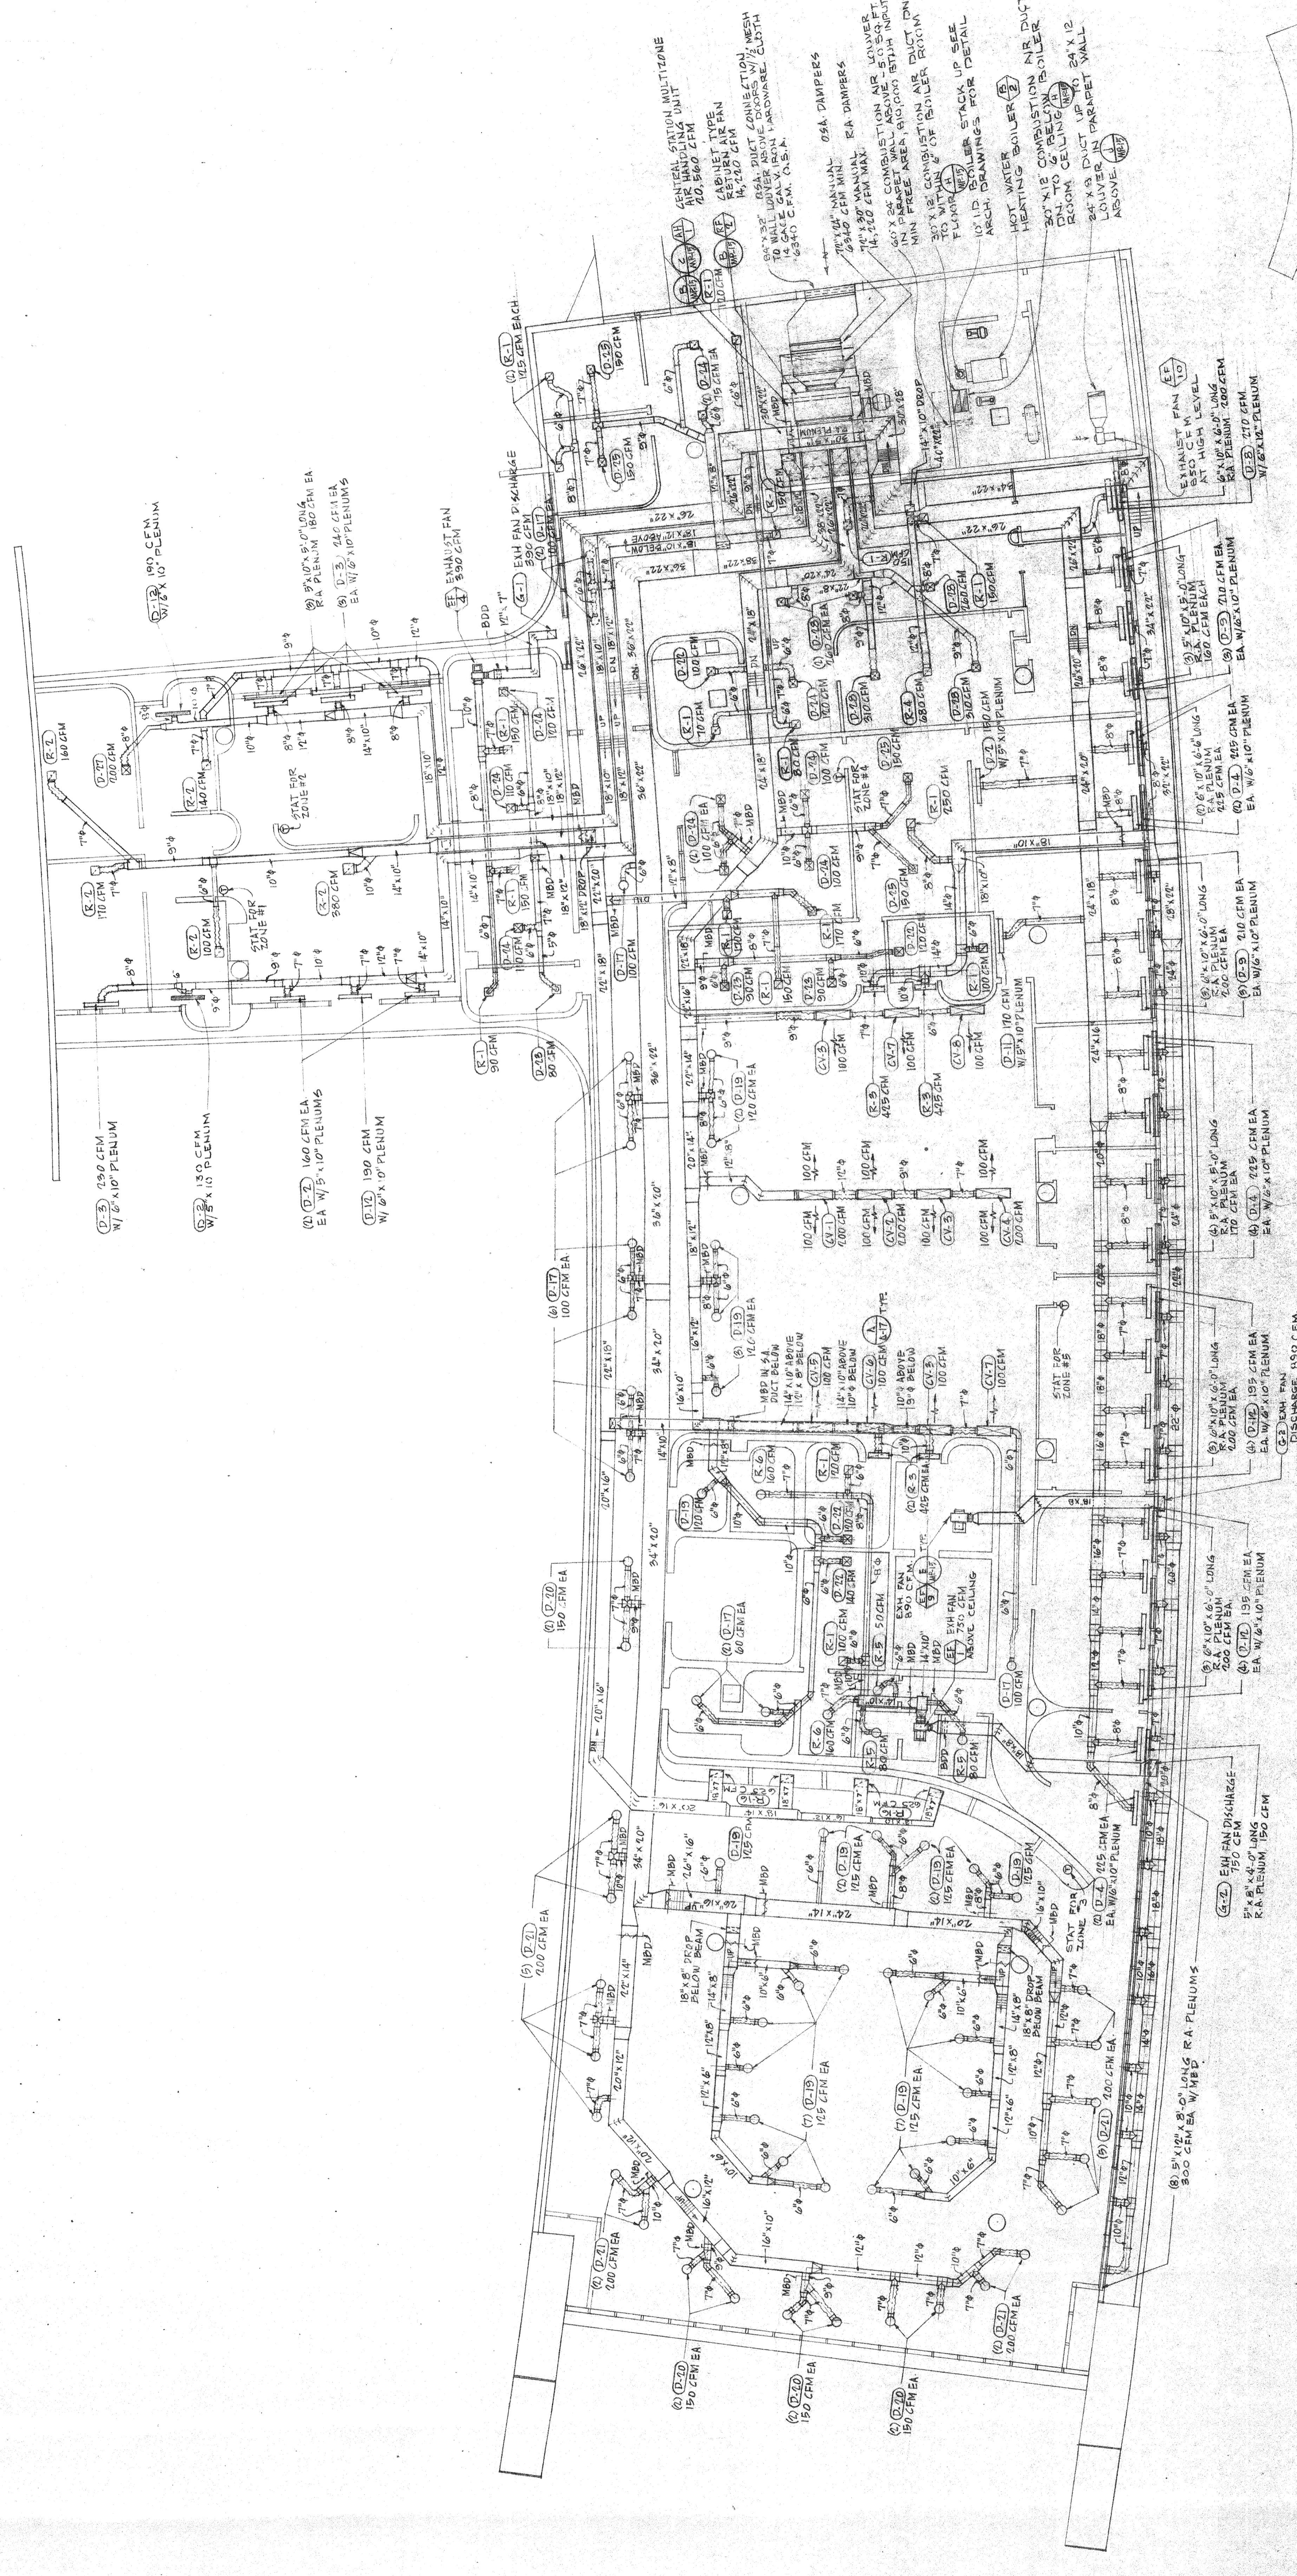

REFLECTED CEILING PLAN
SOUTH BLDG - AIR CONDITIONING
SCALE: 1/8" = 1'-0"

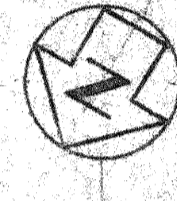

Blaylock Engineers
Mechanical and Electrical Engineering
1909 Wilshire Street, San Diego, Calif. 92101

ROBERT MASON HOUYENAR ARCHITECT
2700 RESEARCH AVENUE, LA JOLLA, CALIFORNIA 92037
TELE: 524-4444